

**Proposed Two Storey Warehouse Complex  
at Thilafushi Plot No.: S5-36  
WAREHOUSE #2**

K. Thilafushi



**DesignExpress**


Architects + Engineers | ☎ +960 7775119  
Registered in Maldives | № SP-2662/2016  
[www.designexpress.mv](http://www.designexpress.mv)

GENERAL NOTES:

1. Do not scale drawings. Dimensions govern
2. All dimensions are in millimeters and all levels are in meters unless noted otherwise
3. All dimensions shall be verified on site before proceeding with work
4. Any areas indicated on this sheet are approximate and indicative only
5. Design Express shall be notified in writing of any discrepancies

REV	DESCRIPTION	DATE
00	INCEPTION	21/04/2021

KEY PLAN

  
**Ministry of National Planning, Housing & Infrastructure**  
**ACCREDITED CHECKER**  
**STRUCTURAL CHECKER A1**  
 Name: Ahmed Haneef  
 Accredited No: BPR2021031A1  
 VALIDITY: 23.03.21 - 22.03.22  
 A1-2021-031-001

  
**Design Express**  
 H. KAFURUTHOLHIJE, JANAVAREE MAGU  
 MALÉ 20042, REPUBLIC OF MALDIVES  
 info@designexpress.mv  
 +960 777 5119  
 © Design Express 2021

CLIENT  
 AASANDHA COMPANY LTD.  
 PROJECT  
 PROPOSED TWO STOREY WAREHOUSE 2 AT PLOT #: S5-36  
 K. THILAFUSHI  
 TITLE  
 DRAWING LIST

DESIGN STAGE

- CONCEPT DESIGN
- DESIGN DEVELOPMENT
- CONSTRUCTION DOCUMENTS
- AS-BUILT DRAWINGS

DRAWN BY	DESIGNED BY	CHECKED BY
DE	HANEEF	HANEEF
DISCIPLINE	SHEET SIZE	SCALE
GENERAL	A3	NA
FIRST EMISSION	DRAWING NUMBER	REVISION
21/04/2021	G-1.01	00
UPDATE	14/09/2021	

**STRUCTURAL SERIES**

#	DRAWING TITLE	DWG #	REV.	REMARKS
16	General notes	S-1.01	00	
17	Foundation plan	S-2.01	00	
18	Ground floor slab plan	S-2.02	00	
19	First floor truss plan	S-2.02	00	
20	Ground floor bracing plan	S-2.02	00	
21	First floor joist plan	S-2.02	00	
22	Roof truss plan	S-2.03	00	
23	First floor bracing plan	S-2.03	00	
24	Roof framing plan	S-2.04	00	
25	Structural details 1	S-5.01	00	
26	Structural details 2	S-5.02	00	
27	Structural details 3	S-5.03	00	
28	Structural details 4	S-5.04	00	
29	Structural details 5	S-5.05	00	
30	Structural details 6	S-5.06	00	
31	Structural details 7	S-5.07	00	
32	Typical details	S-5.08	00	
33	Standard RC detailing rules	S-5.09	00	
34	Foundation protection method	S-5.10	00	

**MEP SERIES**

#	DRAWING TITLE	DWG #	REV.	REMARKS
35	Ground floor electrical layout	E-2.01	00	
36	First floor electrical layout	E-2.02	00	
37	Ground floor plumbing layout	P-2.01	00	
38	Soak pit details	P-5.01	00	

**GENERAL**

#	DRAWING TITLE	DWG #	REV.	REMARKS
01	Drawing list	G-1.01	00	
02	Location plan	G-2.01	00	

**ARCHITECTURAL SERIES**

#	DRAWING TITLE	DWG #	REV.	REMARKS
03	Site plan	A-2.01	00	
04	Ground floor plan	A-2.02	00	
05	First floor plan	A-2.03	00	
06	Roof plan	A-2.04	00	
07	Elevation E1	A-3.01	00	
08	Elevation E2	A-3.02	00	
09	Section(s)	A-4.01	00	
10	Architectural details 1	A-5.01	00	
11	Architectural details 2	A-5.02	00	
12	Door window schedule 1	A-6.01	00	
13	Door window schedule 2	A-6.02	00	
14	Door window schedule 3	A-6.03	00	
15	Ventilation schedule	A-6.04	00	

- G = General
- A = Architectural
- S = Structural
- E = Electrical
- P = Plumbing
- F = Fire protection
- 1 = General
- 2 = Plans
- 3 = Elevations
- 4 = Sections
- 5 = Details
- 6 = Schedules

  
**Ministry of National Planning, Housing & Infrastructure**  
**ACCREDITED CHECKER**  
**ARCHITECTURAL CHECKER B1**  
 Name: Manyam Layana Mohamed  
 Accredited No: BPR2021031B1  
 VALIDITY: 02.05.21 - 22.03.22  
 B1-2021-031-001

01 Drawing list

**GENERAL NOTES:**

- 1. Do not scale drawings. Dimensions govern.
- 2. All dimensions are in millimeters and all levels are in meters unless noted otherwise
- 3. All dimensions shall be verified on site before proceeding with work
- 4. Any areas indicated on this sheet are approximate and indicative only
- 5. Design Express shall be notified in writing of any discrepancies

REV	DESCRIPTION	DATE
00	INCEPTION	21/04/2021

KEY PLAN

Ministry of National Planning, Housing & Infrastructure  
**ACCREDITED CHECKER**  
**STRUCTURAL CHECKER A1**  
 Name: Ahmed Hameed  
 Validity: 23.03.21 - 22.03.22  
 Accredited No: BPR2021031A1 A1-2021-031-001

**DesignExpress**  
 H. KAFURUTHOLIGE, JANAVAREE MAGU  
 MALE 20042, REPUBLIC OF MALDIVES  
 info@designexpress.mv +960 777 5119 © Design Express 2021

CLIENT  
**AASANDHA COMPANY LTD.**  
 PROJECT  
**PROPOSED TWO STOREY WAREHOUSE 2 AT PLOT #: S5-36**  
 K. THILAFUSHI


TITLE  
**LOCATION PLAN**

- DESIGN STAGE
- CONCEPT DESIGN
  - DESIGN DEVELOPMENT
  - CONSTRUCTION DOCUMENTS
  - AS-BUILT DRAWINGS

DRAWN BY	DESIGNED BY	CHECKED BY		SHEET SIZE		SCALE	
		DE	HANEEF	HANEEF	HANEEF	A3	1:500
GENERAL	FIRST EMISSION	DRAWING NUMBER	REVISION	21/04/2021	G-2.01	00	
UPDATE	14/09/2021						

Ministry of National Planning, Housing & Infrastructure  
**ACCREDITED CHECKER**  
**ARCHITECTURAL CHECKER B1**  
 Name: Maryam Layana Mohamed  
 Validity: 02.03.21 - 22.03.22  
 Accredited No: BPR2021031B1 B1-2021-031-001

Ministry of National Planning, Housing & Infrastructure  
**ACCREDITED CHECKER**  
**ARCHITECTURAL CHECKER B1**  
 Name: Maryam Layana Mohamed  
 Validity: 02.03.21 - 22.03.22  
 Accredited No: BPR2021031B1 B1-2021-031-001

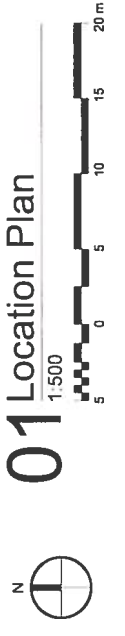


**GENERAL NOTES:**

- Do not scale drawings. Dimensions govern
- All dimensions are in millimeters and all levels are in meters unless noted otherwise
- All dimensions shall be verified on site before proceeding with work
- Any areas indicated on this sheet are approximate and indicative only
- Design Express shall be notified in writing of any discrepancies

REV	DESCRIPTION	DATE
00	INCEPTION	21/04/2021

KEY PLAN

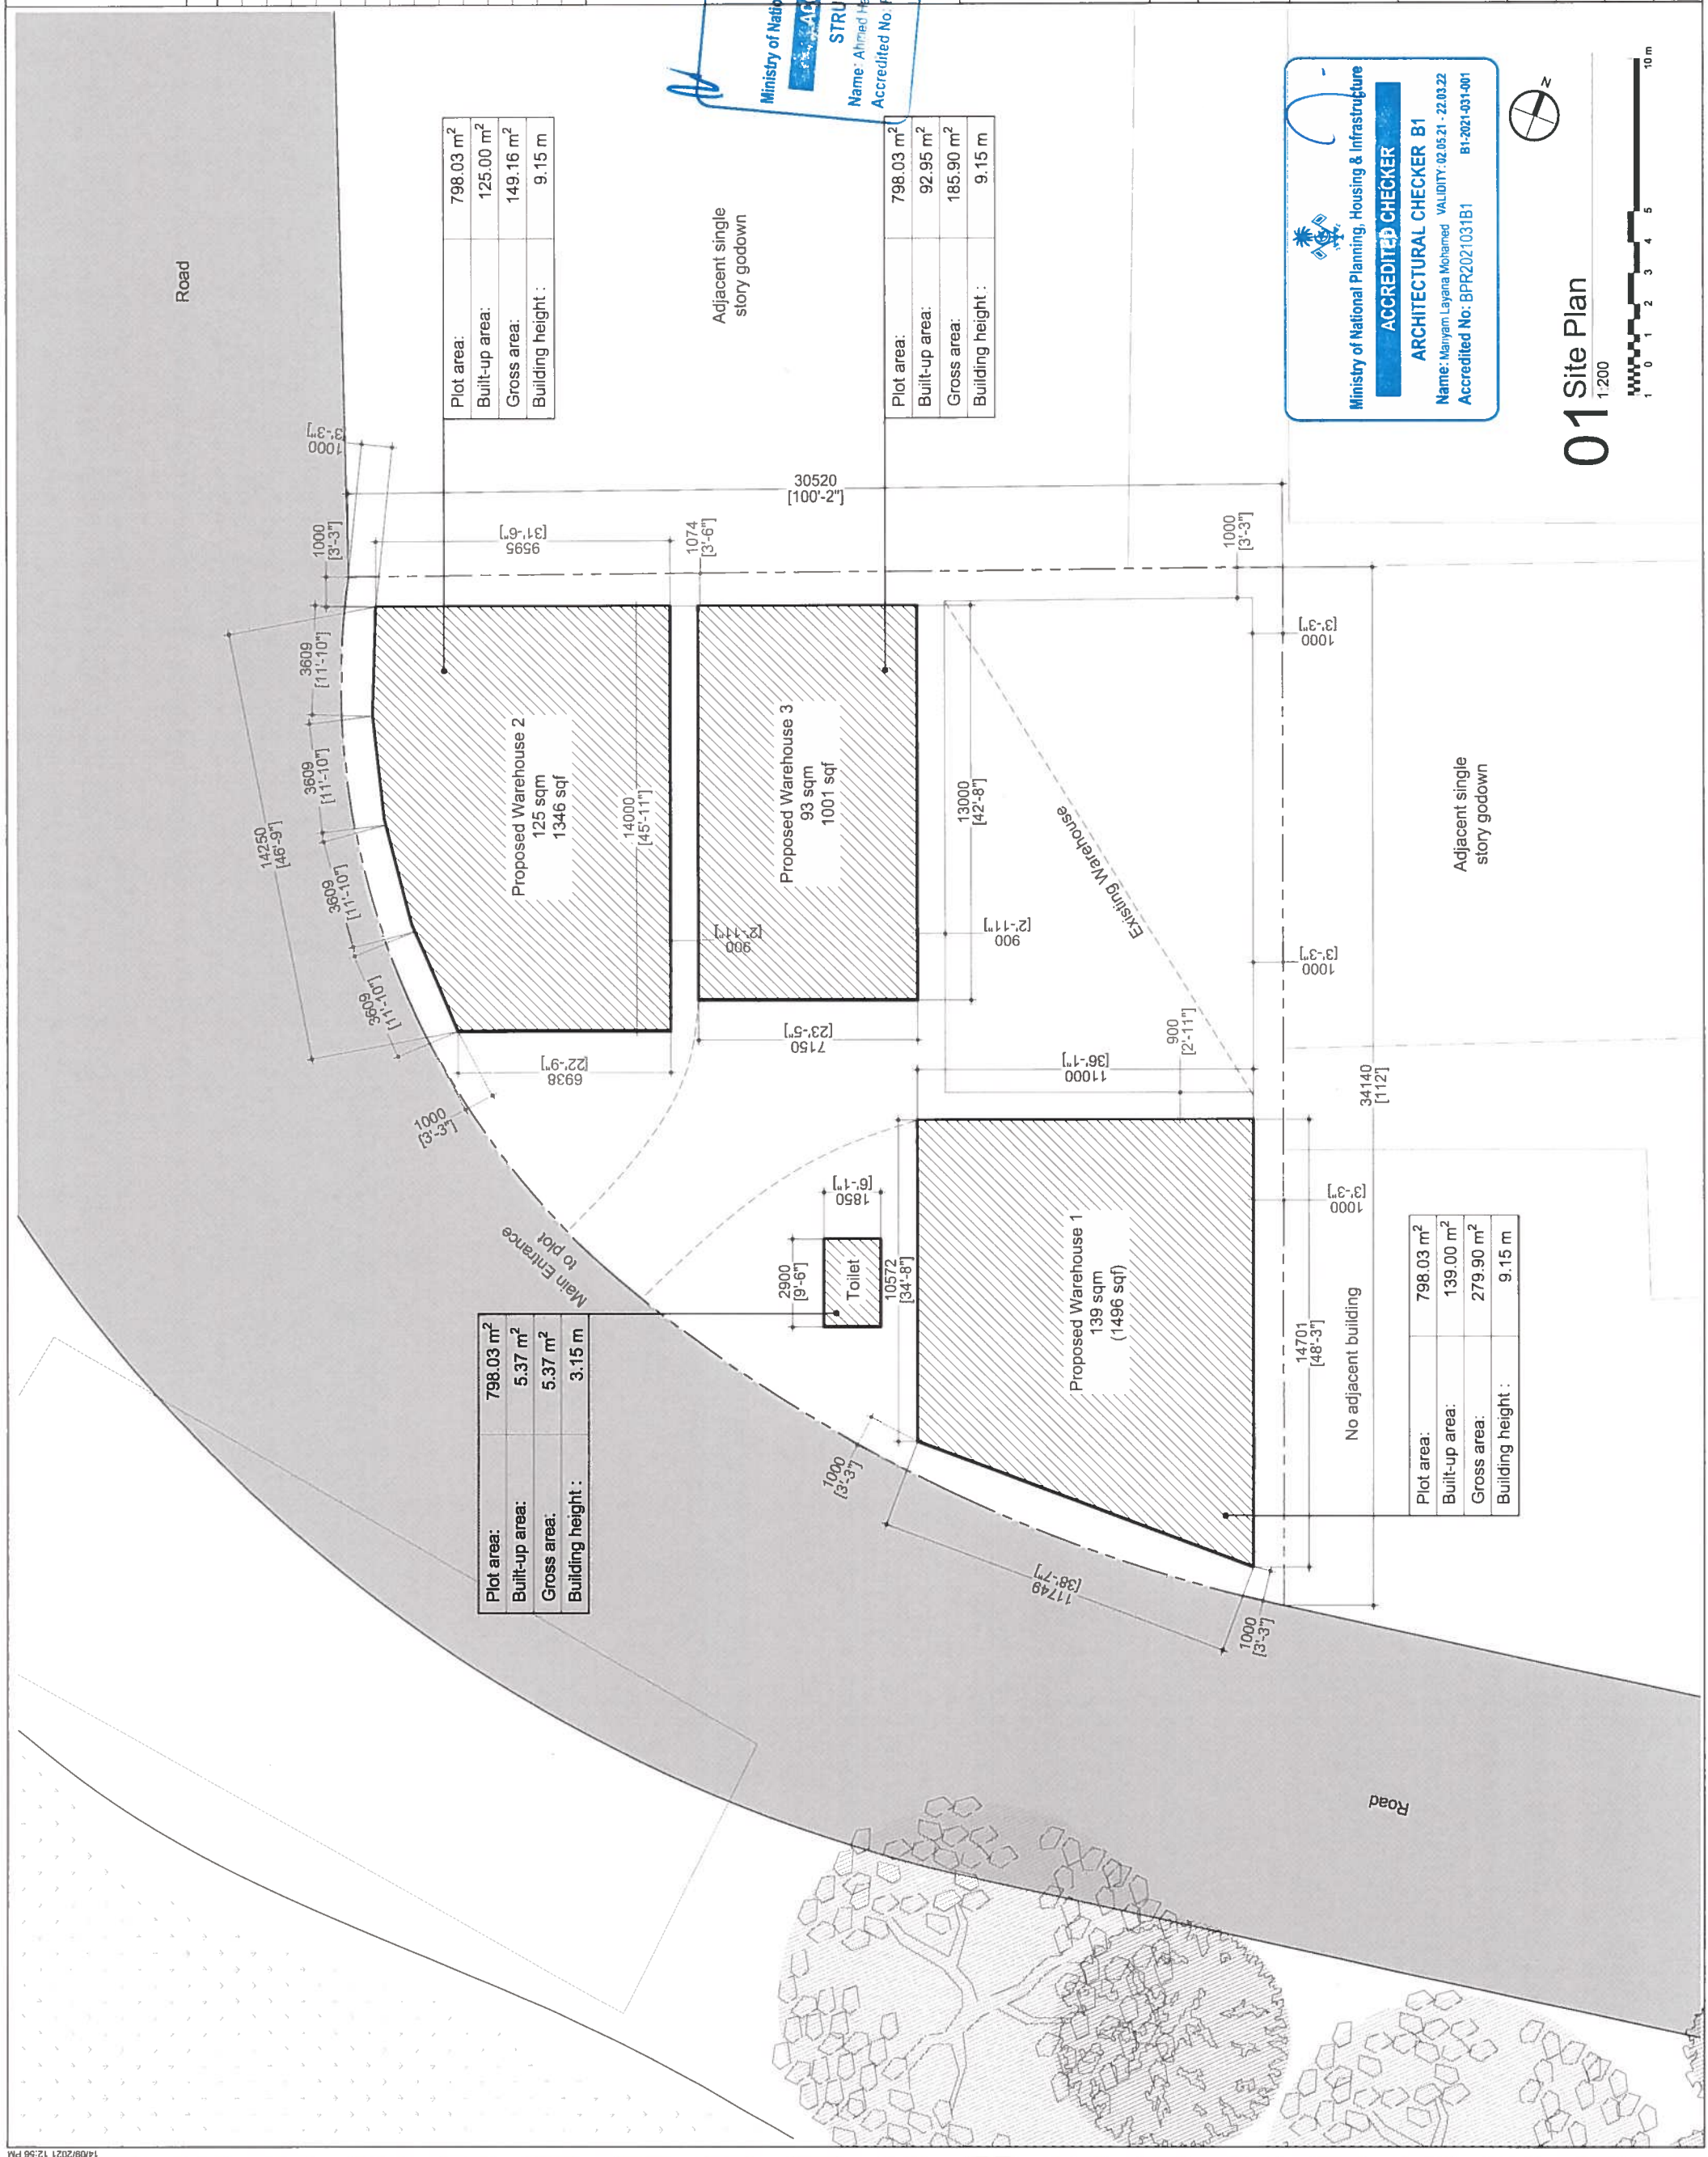

Plot area:	798.03 m <sup>2</sup>
Built-up area:	125.00 m <sup>2</sup>
Gross area:	149.16 m <sup>2</sup>
Building height :	9.15 m

Plot area:	798.03 m <sup>2</sup>
Built-up area:	92.95 m <sup>2</sup>
Gross area:	185.90 m <sup>2</sup>
Building height :	9.15 m

Plot area:	798.03 m <sup>2</sup>
Built-up area:	139.00 m <sup>2</sup>
Gross area:	279.90 m <sup>2</sup>
Building height :	9.15 m

Ministry of National Planning, Housing & Infrastructure  
**ACCREDITED CHECKER**  
**STRUCTURAL CHECKER A1**  
 Name: Ahmed Hameed  
 Accredited No: B/R/2021031A1  
 VALIDITY: 23.03.21 - 22.03.22  
 A1-2021-031-001

Ministry of National Planning, Housing & Infrastructure  
**ACCREDITED CHECKER**  
**ARCHITECTURAL CHECKER B1**  
 Name: Manyam Layana Mohamed  
 Accredited No: BPR2021031B1  
 VALIDITY: 02.05.21 - 22.03.22  
 B1-2021-031-001

**DesignExpress**  
 H. KAFURUTHOLHIGE, JANAVAREE MAGU  
 MALE 20042, REPUBLIC OF MALDIVES  
 info@designexpress.mv  
 +960 777 5119  
 © Design Express 2021

CLIENT: AASANDHA COMPANY LTD.  
 PROJECT: PROPOSED TWO STOREY WAREHOUSE 2 AT PLOT #: S5-36  
 K. THILAFUSHI

TITLE: **SITE PLAN**

DESIGN STAGE:  
 CONCEPT DESIGN  
 DESIGN DEVELOPMENT  
 CONSTRUCTION DOCUMENTS  
 AS-BUILT DRAWINGS

DRAWN BY: ISHA  
 CHECKED BY: LAYANA

DISCIPLINE: ARCHITECTURAL  
 SHEET SIZE: A3  
 SCALE: 1:200

FIRST EMISSION: 21/04/2021  
 DRAWING NUMBER: A-2.01  
 REVISION: 00  
 UPDATE: 14/09/2021

**01 Site Plan**  
 1:200

# 01 WAREHOUSE 2: Ground Floor Plan



1:100




## GENERAL NOTES:

- 1. Do not scale drawings. Dimensions govern.
- 2. All dimensions are in millimeters and all levels are in meters unless noted otherwise.
- 3. All dimensions shall be verified on site before proceeding with work.
- 4. Any areas indicated on this sheet are approximate and indicative only.
- 5. Design Express shall be notified in writing of any discrepancies.

REV	DESCRIPTION	DATE
00	INCEPTION	21/04/2021

KEY PLAN

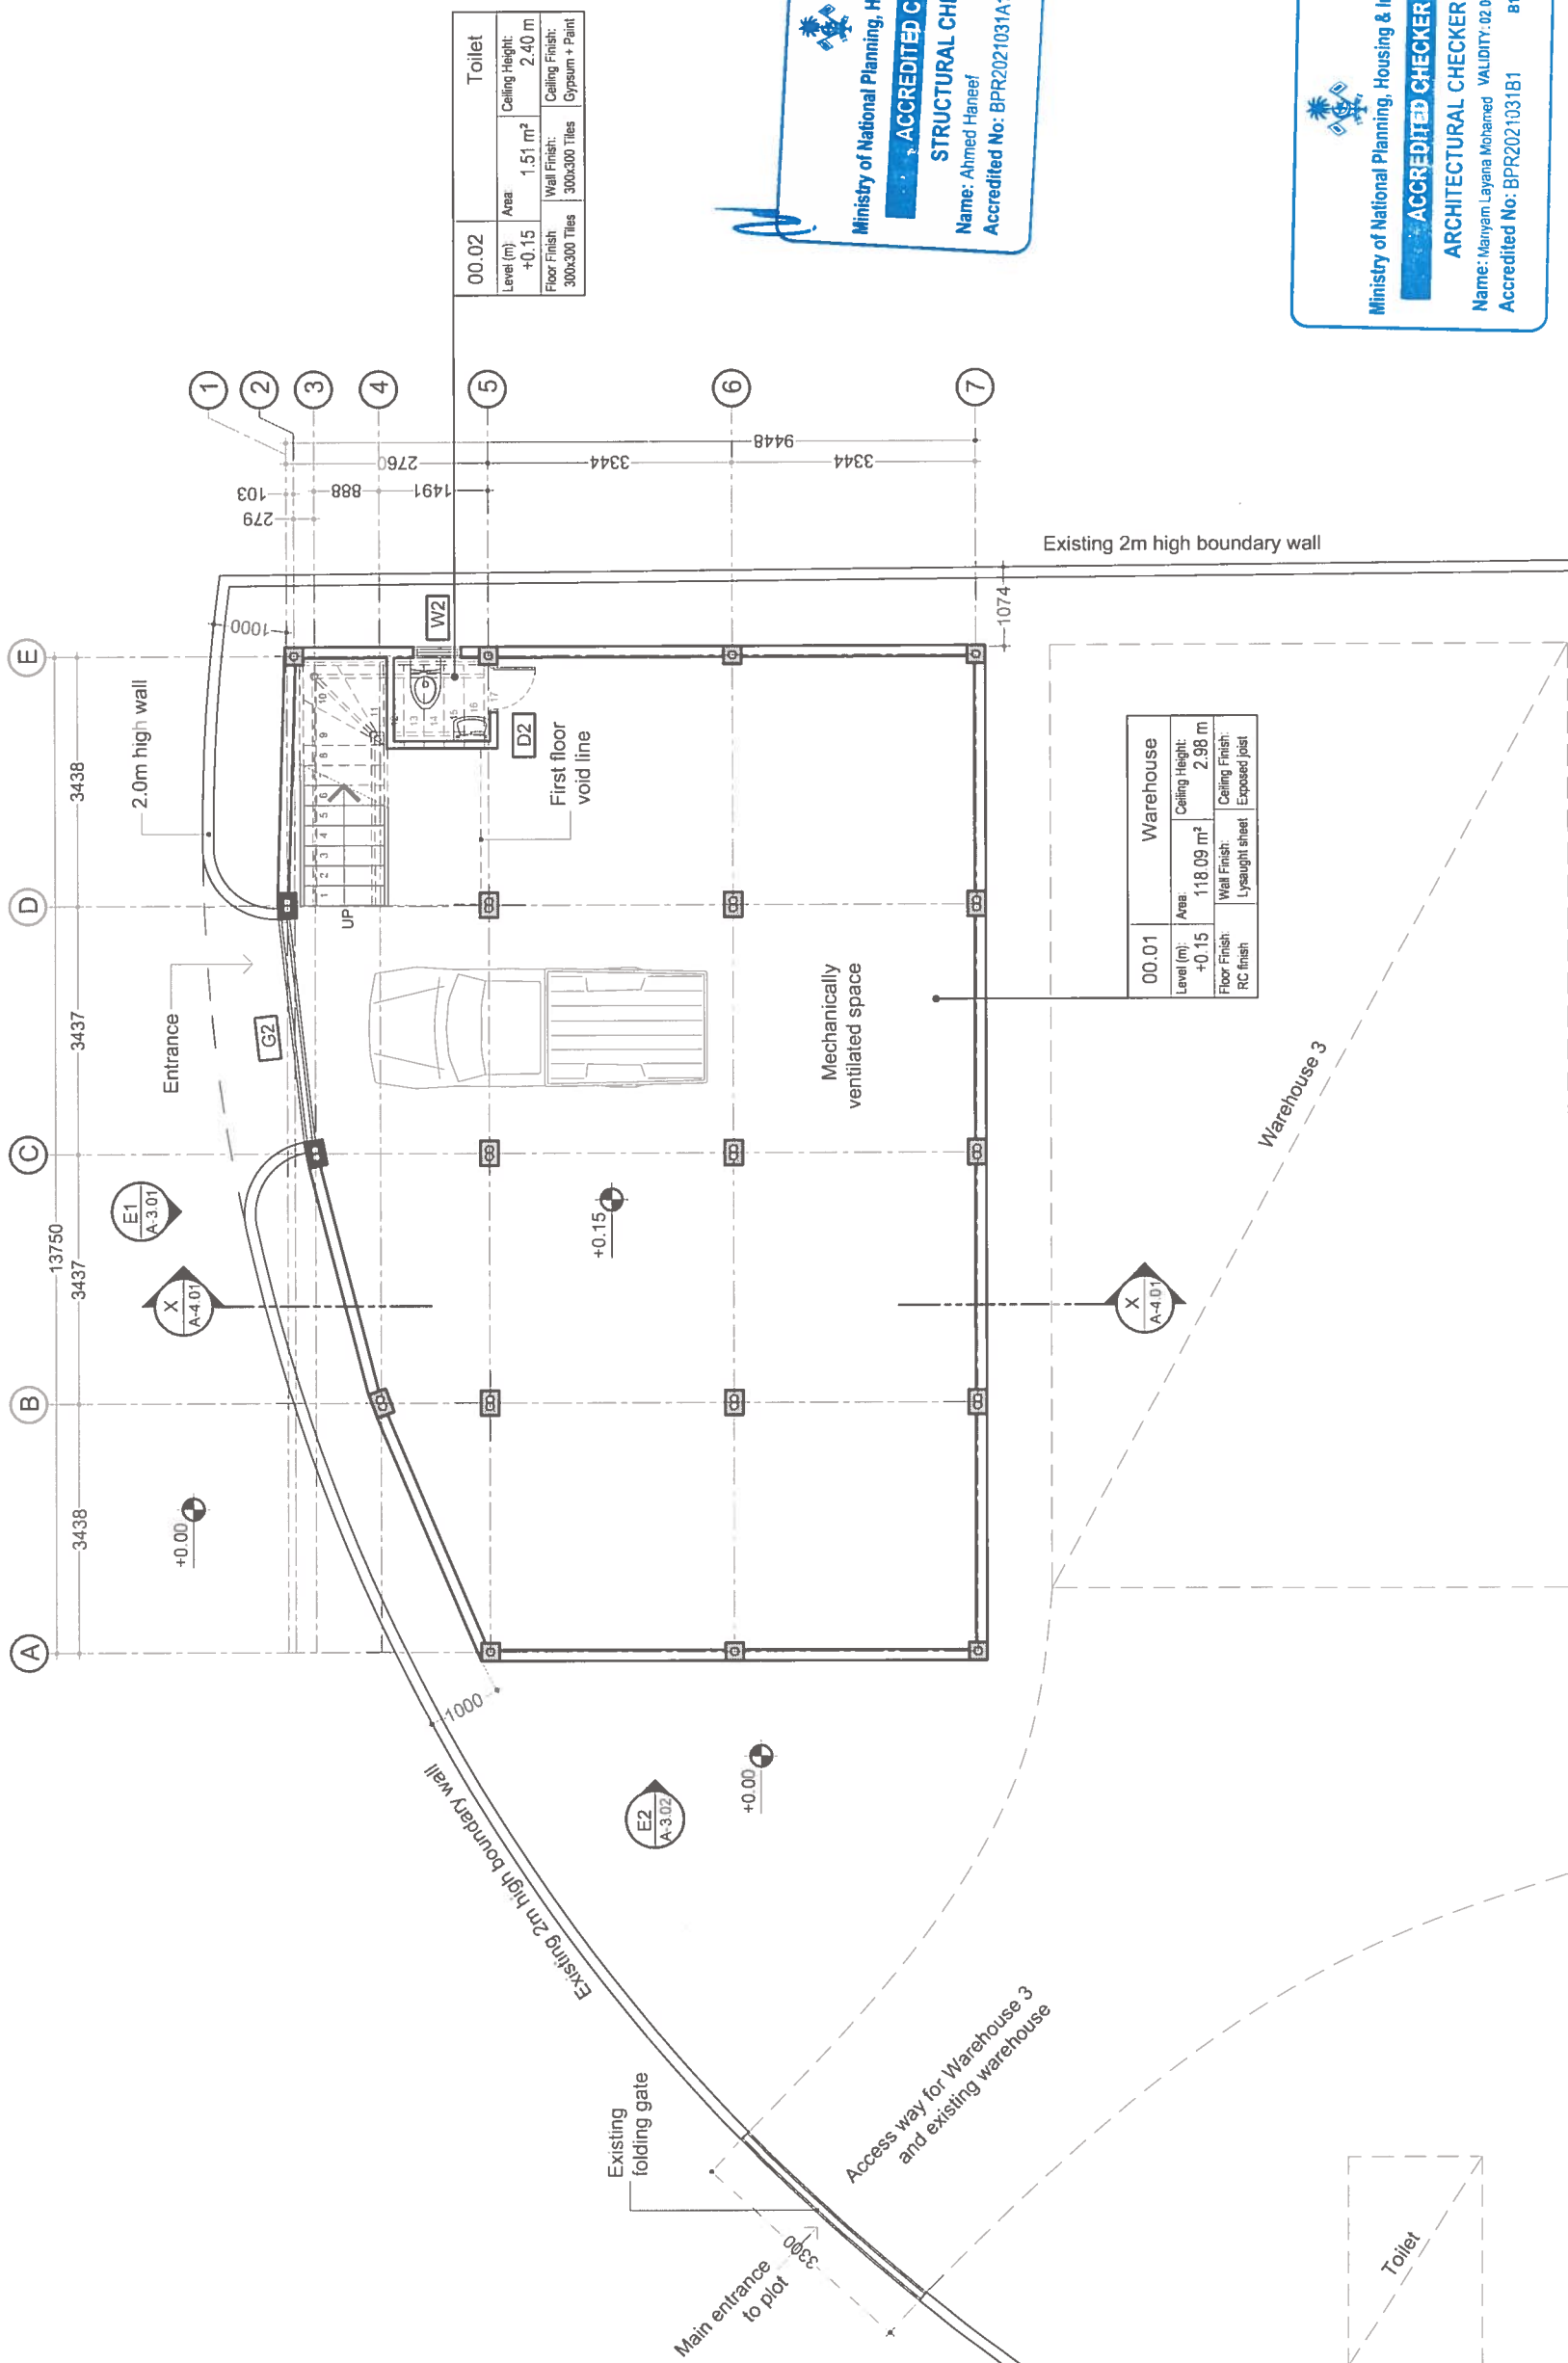

00.02 Toilet			
Level (m):	Area:	Ceiling Height:	
+0.15	1.51 m <sup>2</sup>	2.40 m	
Floor Finish:	Wall Finish:	Ceiling Finish:	
300x300 Tiles	300x300 Tiles	Gypsum + Paint	

Warehouse			
Level (m):	Area:	Ceiling Height:	
+0.15	118.09 m <sup>2</sup>	2.98 m	
Floor Finish:	Wall Finish:	Ceiling Finish:	
RC finish	Lysalight sheet	Exposed Joist	



**DesignExpress**  
 H. KAFURTHOLHIGE, JANAVAREE MAGU  
 MALÉ 20042, REPUBLIC OF MALDIVES  
 info@designexpress.mv  
 +960 777 5119  
 © Design Express 2021

CLIENT: AASANDHA COMPANY LTD.

PROJECT: PROPOSED TWO STOREY WAREHOUSE 2 AT PLOT #: S5-36  
 K. THILAFUSHI

TITLE: GROUND FLOOR PLAN

DESIGN STAGE:  
 CONCEPT DESIGN  
 DESIGN DEVELOPMENT  
 CONSTRUCTION DOCUMENTS  
 AS-BUILT DRAWINGS

DRAWN BY: DE  
 DESIGNED BY: ISHA  
 CHECKED BY: LAYANA

DISCIPLINE: ARCHITECTURAL  
 SHEET SIZE: A3  
 SCALE: 1:100

FIRST EMISSION: 21/04/2021  
 DRAWING NUMBER: A-2.02  
 REVISION: 00  
 UPDATE: 14/09/2021



Ministry of National Planning, Housing & Infrastructure  
**ACCREDITED CHECKER**  
**STRUCTURAL CHECKER A1**


Name: Ahmed Hameed  
 Validity: 23.03.21 - 22.03.22  
 Accredited No: BPR2021031A1 A1-2021-031-001




Ministry of National Planning, Housing & Infrastructure  
**ACCREDITED CHECKER**  
**ARCHITECTURAL CHECKER B1**

Name: Maryam Layana Mohamed  
 Validity: 02.05.21 - 22.03.22  
 Accredited No: BPR2021031B1 B1-2021-031-001

# 01 WAREHOUSE 2: First Floor Plan

 

1:100

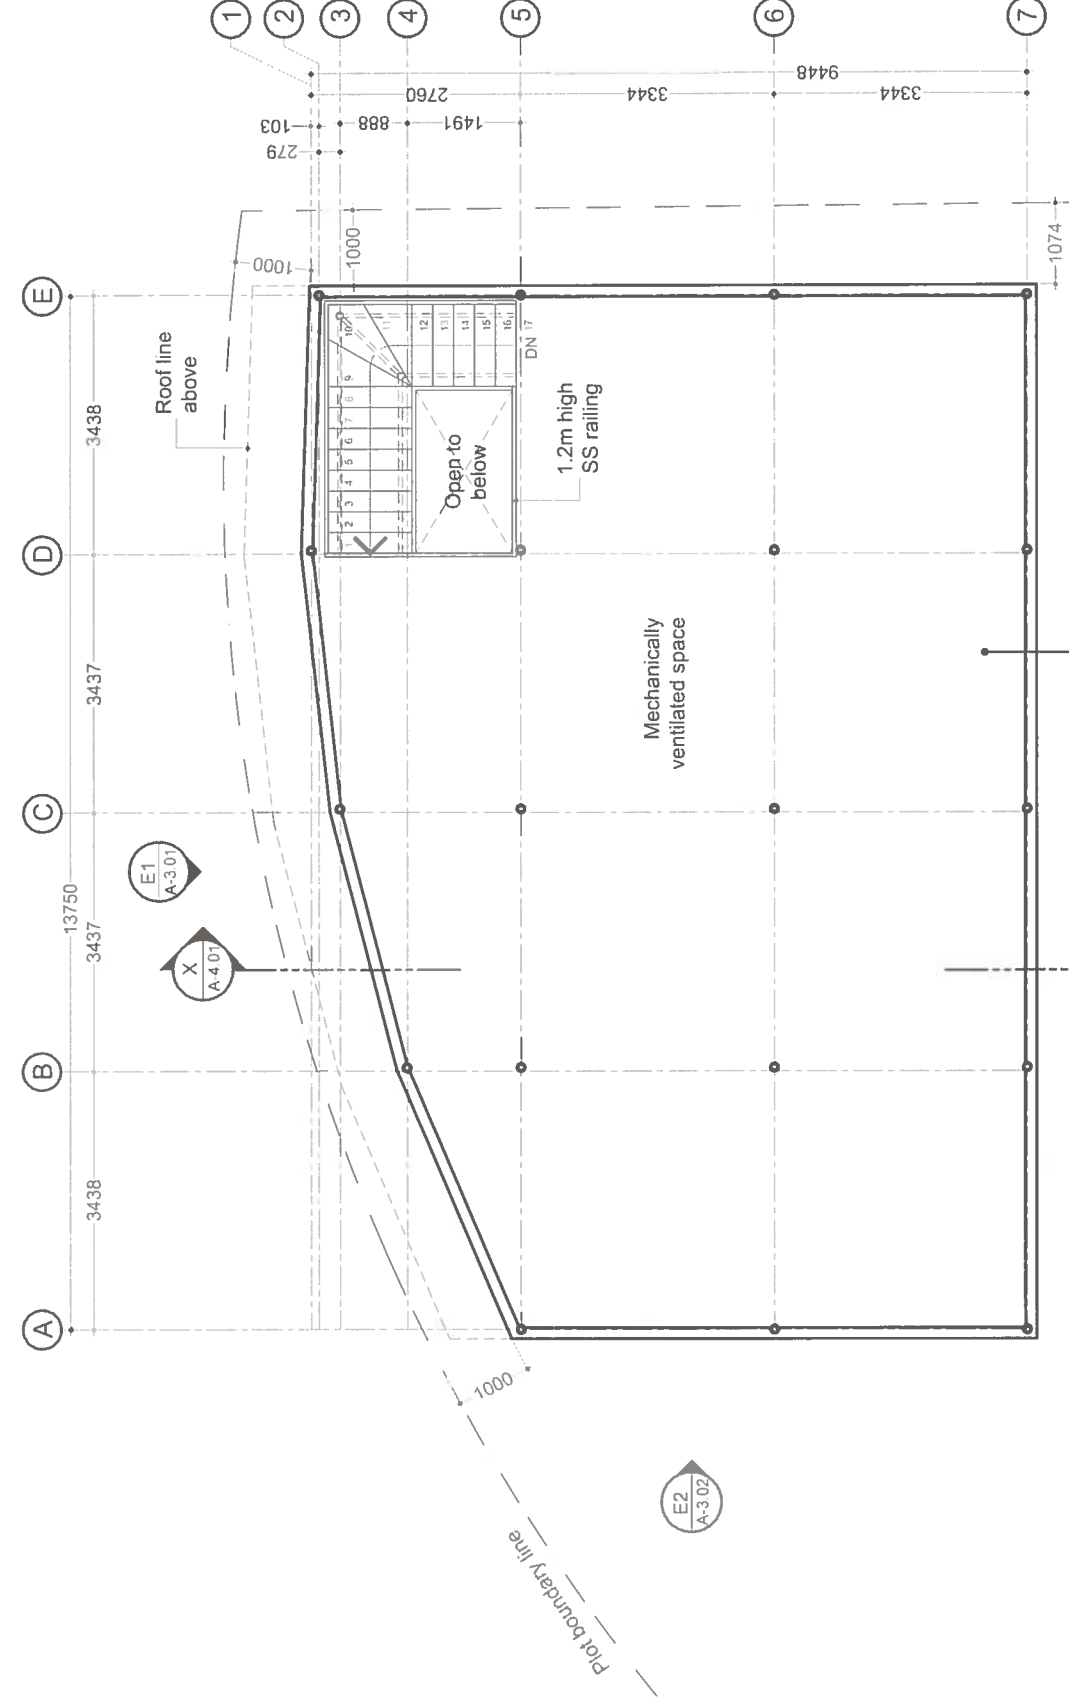

Plot boundary line

Warehouse			
01.01	Area	Ceiling Height	
	109.79 m <sup>2</sup>	2.90 m	
Level (m)	+3.30	Floor Finish	Ceiling Finish
		Lysaght sheet	Exposed rafters

Ministry of National Planning, Housing & Infrastructure
   
**ACCREDITED CHECKER**
  
**STRUCTURAL CHECKER A1**
  
 Name: Ahmed Haneef      VALIDITY: 23.03.21 - 22.03.22
   
 Accredited No: BPR2021031A1      /A1-2021-031-001

Ministry of National Planning, Housing & Infrastructure
   
**ACCREDITED CHECKER**
  
**ARCHITECTURAL CHECKER B1**
  
 Name: Maniyam Layana Mohamed      VALIDITY: 02.05.21 - 22.03.22
   
 Accredited No: BPR2021031B1      /B1-2021-031-001

- GENERAL NOTES**
- Do not scale drawings. Dimensions govern
  - All dimensions are in millimeters and all levels are in meters unless noted otherwise
  - All dimensions shall be verified on site before proceeding with work
  - Any areas indicated on this sheet are approximate and indicative only
  - Design Express shall be notified in writing of any discrepancies

REV	DESCRIPTION	DATE
00	INCEPTION	21/04/2021

KEY PLAN



**DesignExpress**
  
 H. KAFURUTHOLIGE, JANAVAREE MAGU
   
 MALE 20042, REPUBLIC OF MALDIVES
   
 info@designexpress.mv
   
 +960 777 5119      © Design Express 2021

CLIENT: AASANDHA COMPANY LTD.
   
 PROJECT: PROPOSED TWO STOREY WAREHOUSE 2 AT PLOT #: S5-36
   
 K. THILAFUSHI

TITLE: FIRST FLOOR PLAN

- DESIGN STAGE
- CONCEPT DESIGN
  - DESIGN DEVELOPMENT
  - CONSTRUCTION DOCUMENTS
  - AS-BUILT DRAWINGS

DRAWN BY	DESIGNED BY	CHECKED BY	SHEET SIZE	SCALE
DE	ISHA	LAYANA	A3	1:100

DISCIPLINE	DRAWING NUMBER	REVISION
ARCHITECTURAL	A3	1


FIRST EMISSION	DATE	UPDATE
21/04/2021		14/09/2021

A-2.03 00



# 01 WAREHOUSE 2: Roof Plan

1:100

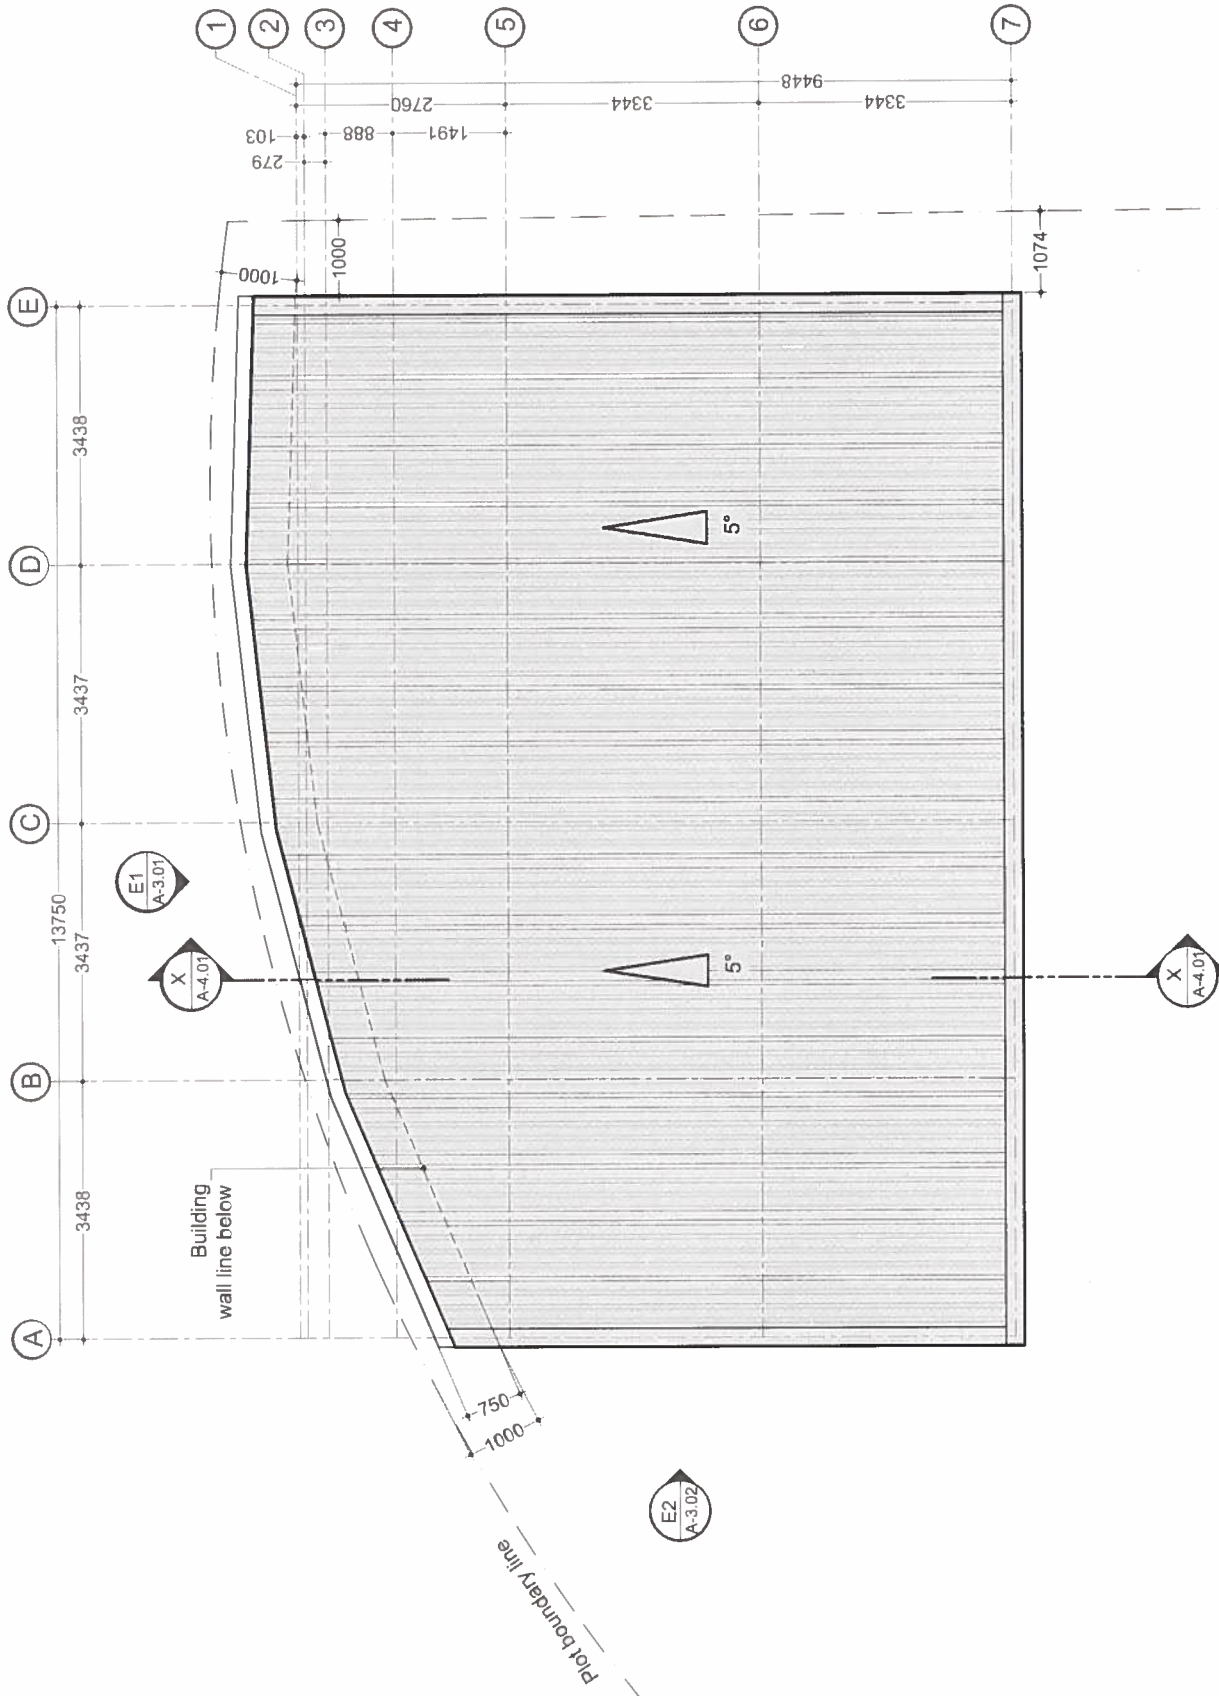

- GENERAL NOTES:**
- Do not scale drawings. Dimensions govern
  - All dimensions are in millimeters and all levels are in meters unless noted otherwise
  - All dimensions shall be verified on site before proceeding with work
  - Any areas indicated on this sheet are approximate and indicative only
  - Design Express shall be notified in writing of any discrepancies

REV	DESCRIPTION	DATE
00	INCEPTION	21/04/2021

KEY PLAN

**ACCREDITED CHECKER**

Ministry of National Planning, Housing & Infrastructure

**STRUCTURAL CHECKER A1**

Name: Ahmed Haneef     VALIDITY: 23.03.21 - 22.03.22  
Accredited No: BPR2021031A1     A1-2021-031-001

**DesignExpress**

H. KAFURUTHOLHIGE, JANAVAREE MAGU  
MALE 20042, REPUBLIC OF MALDIVES  
✉ info@designexpress.mv     ☎ +960 777 5119  
© Design Express 2021

CLIENT  
**AA SANDHA COMPANY LTD.**

PROJECT  
**PROPOSED TWO STOREY WAREHOUSE 2 AT PLOT #: S5-36**  
K. THILAFUSHI

TITLE  
**ROOF PLAN**

DESIGN STAGE			
<input type="radio"/> CONCEPT DESIGN	DESIGNED BY	CHECKED BY	
<input type="radio"/> DESIGN DEVELOPMENT	ISHA	LAYANA	
<input checked="" type="radio"/> CONSTRUCTION DOCUMENTS			
<input type="radio"/> AS-BUILT DRAWINGS			
DRAWN BY		DISCIPLINE	
		ARCHITECTURAL A3	
SHEET SIZE		SCALE	
1:100		1:100	
FIRST EMISSION	DRAWING NUMBER	REVISION	
21/04/2021	A-2.04	00	
UPDATE			
14/09/2021			

**ACCREDITED CHECKER**

Ministry of National Planning, Housing & Infrastructure

**ARCHITECTURAL CHECKER B1**

Name: Mervan Layana Mohamed     VALIDITY: 02.05.21 - 22.03.22  
Accredited No: BPR2021031B1     B1-2021-031-001